





REV	DESCRIPTION	DATE	BY	CHK
C	Updated AC unit location	19/01/2020	JC	MS
B	Low level power updated	04/02/2020	JC	MS
A	Desk layout updated & power points updated	29/01/2020	JC	MS
000	Issue for construction			

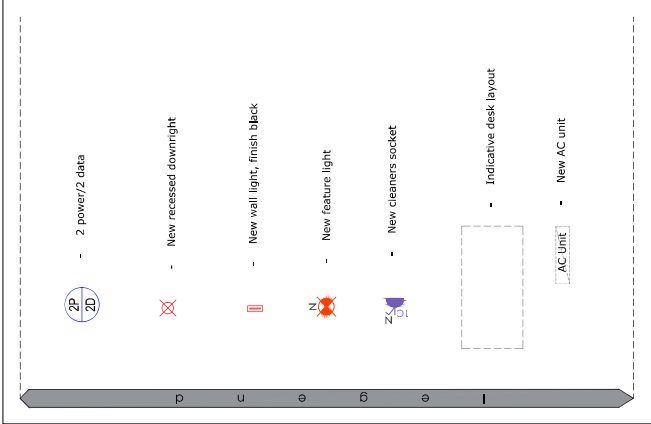

www.roseinteriors.co.uk 0203 731 116 0203 731 116 150 Broad Street, London, EC2M 2DF	
General Arrangement	
Client Name:	New Cavendish Street
Date:	07/01/2020
Project Address:	New Cavendish Street London
Scale:	1:50 (B/A)
Drawn by:	JJC
Checked by:	MS
Rev:	03
Sheet:	GA
Revision:	C

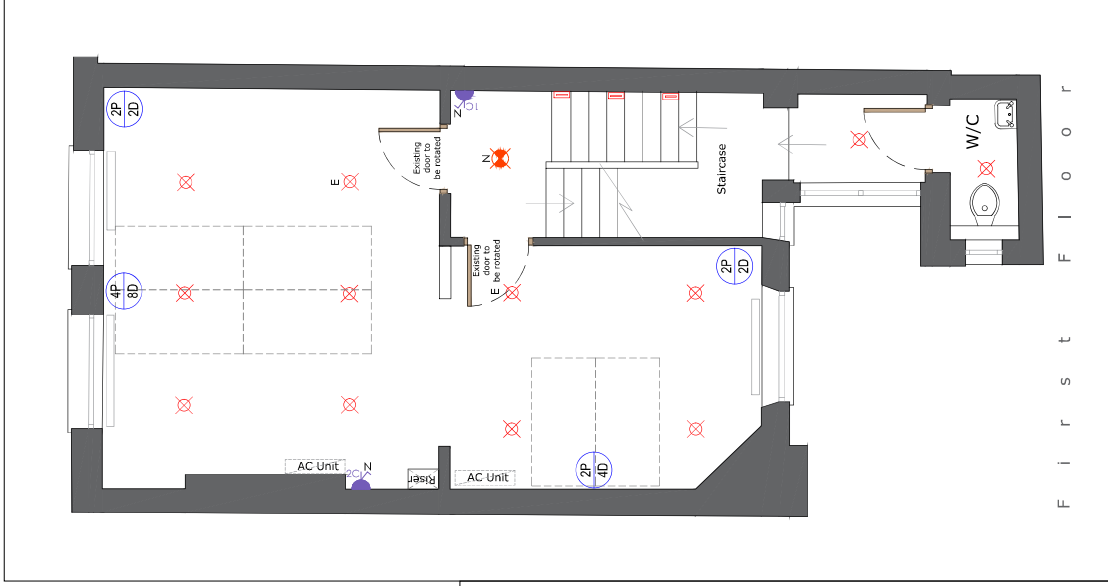

REVISIONS		<p>The drawings are the property of RISE Interiors and shall not be used for any other project without the written consent of RISE Interiors. Any unauthorized use or reproduction of these drawings is strictly prohibited. RISE Interiors shall not be held responsible for any errors or omissions in these drawings. The client shall be responsible for providing accurate information and for obtaining all necessary permits and approvals. The drawings are provided on the basis of the information provided by the client. RISE Interiors shall not be held responsible for any changes or modifications to the drawings after the date of issue. The drawings are provided on the basis of the information provided by the client. RISE Interiors shall not be held responsible for any changes or modifications to the drawings after the date of issue.</p>	
B	Low level power updated	06/02/2020	JC MS
A	Desk layout added & power points updated	27/01/2020	JC MS
REV	DATE	BY	CHK
<p>Client Name: RISE Interiors Project Name: RISE Interiors</p>		<p>Drawn by: JD Date: 06/02/2020</p>	
<p>Website: www.riseinteriors.co.uk Email: info@riseinteriors.co.uk Phone: 02030000000</p>			
<p>General Arrangement</p>			
<p>Client Name: New Cavendish Street</p>		<p>Project Address: New Cavendish Street London</p>	
Date:	07/01/2020	Project Name:	New Cavendish Street London
Scale:	1:50 (B/A)	Floor:	01
Drawn by:	JD	Client:	CA
Revision:	8		

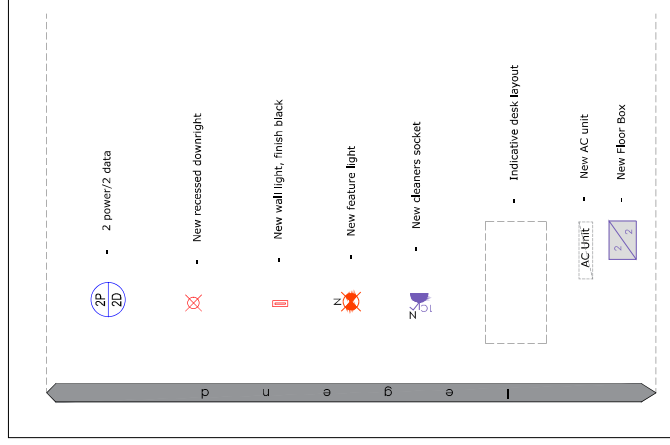
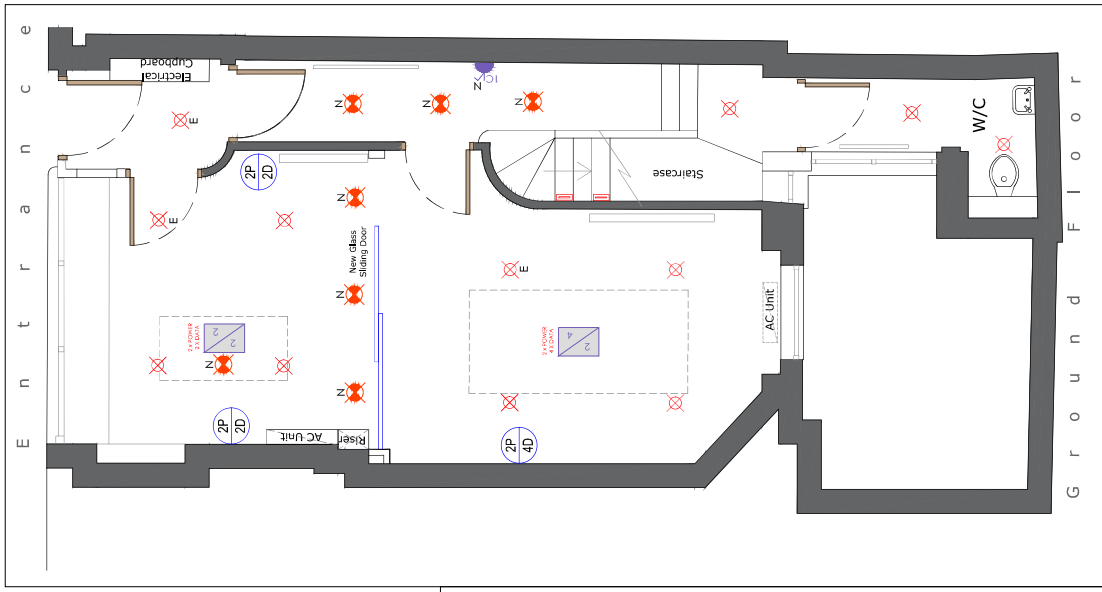


<p>DISCLAIMER</p> <p>This document is the property of RISE INTERIORS and is intended for use by the client only. It is not to be used for any other purpose without the written consent of RISE INTERIORS. RISE INTERIORS shall not be held responsible for any errors or omissions in this document. The client shall be responsible for ensuring that all information provided is accurate and up-to-date. RISE INTERIORS shall not be held responsible for any damage or loss of data resulting from the use of this document.</p>				
B	Client sitting area added & low level power updated	16/01/2020	AC	1A6
A	Desk layout added & power layout updated	17/01/2020	AC	1A6
REV	DATE	BY	CA	
<p>Client Name: New Coventish Street</p> <p>Project Address: New Coventish Street London</p> <p>Scale: 1:50 (B/A)</p> <p>Drawn by: ND</p> <p>Check by: 01</p> <p>Revision: 8</p>				



www.rioseinteriors.co.uk | 0203 1234 567 | 100 Broad Street, London, W1P 3JF

General Arrangement

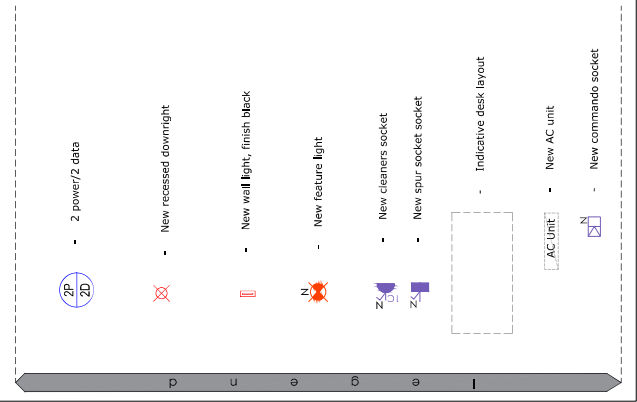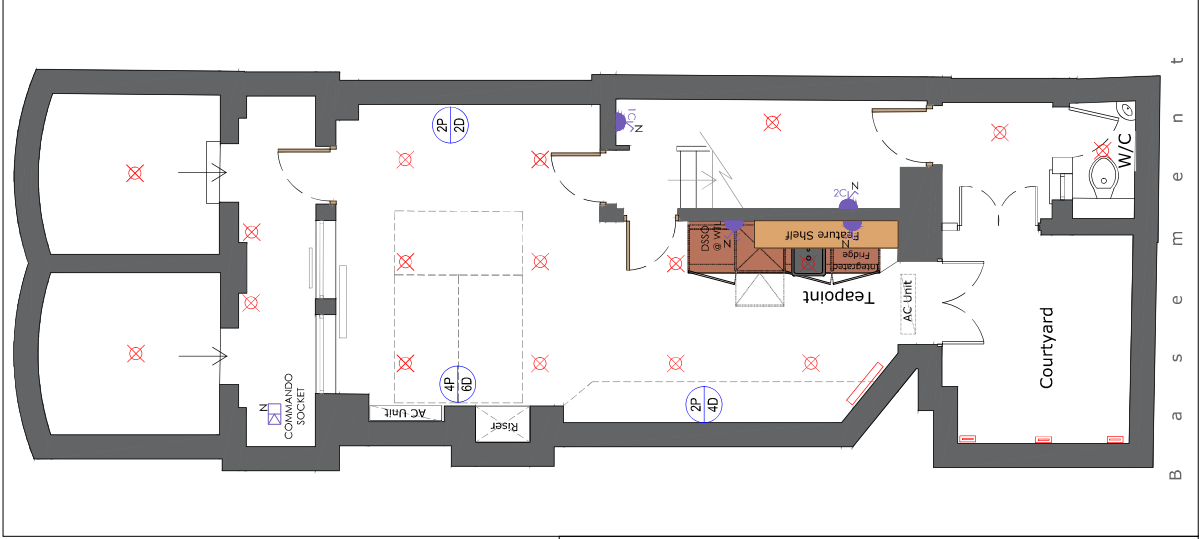

DESCRIPTION		DATE	BY	CHK
B	Low level power updated	04/02/2020	JC	MS
A	Desk layout updated & power points updated	29/01/2020	JC	MS

RISE INTERIORS www.rioseinteriors.com 0203 701 1234 The Covered Pavement 100A London EC1A 3DF Telephone: 0203 701 1234 Email: info@rioseinteriors.com	
Description: General Arrangement	
Client Name: New Coverditch Street	
Date: 07/01/2020	Project Address: New Coverditch Street London
Scale: 1:50 (B/A)	Floor: 1st
DWG NO: #24P	DWG: CA
NO:	Revision: 8