


③

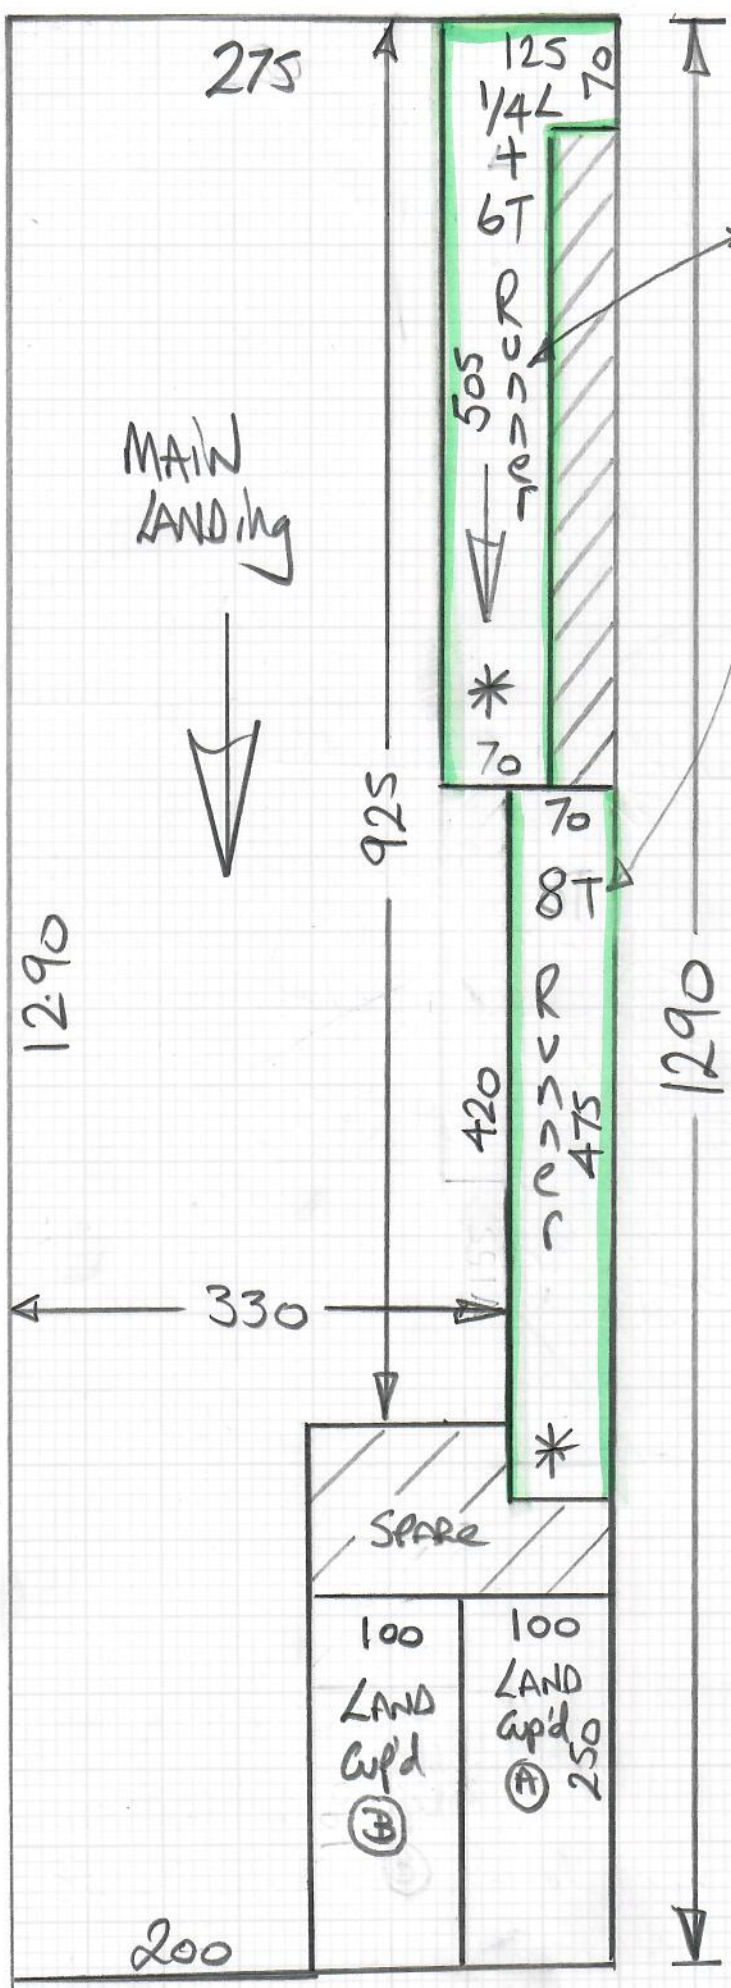

Phase 2

Job No: R18826
 Name: Indie Interiors
 Address: Heronswood
 Tel:
 Sheet: (1 of 3)

Flatweave Classics
Big boude-Down

Cut Plan ③ 13.00 x 400
 = 52m²

Taping = 21 Lin Mtrs


U/Lay =
 System 10 for landing
 = 35m²

Low tog for Runners
 = 8m²

mrcarpet
 R18826
 Indie Interiors
 Hertswood

2 of 3

Flatweave Classics
Big Boude-Daan

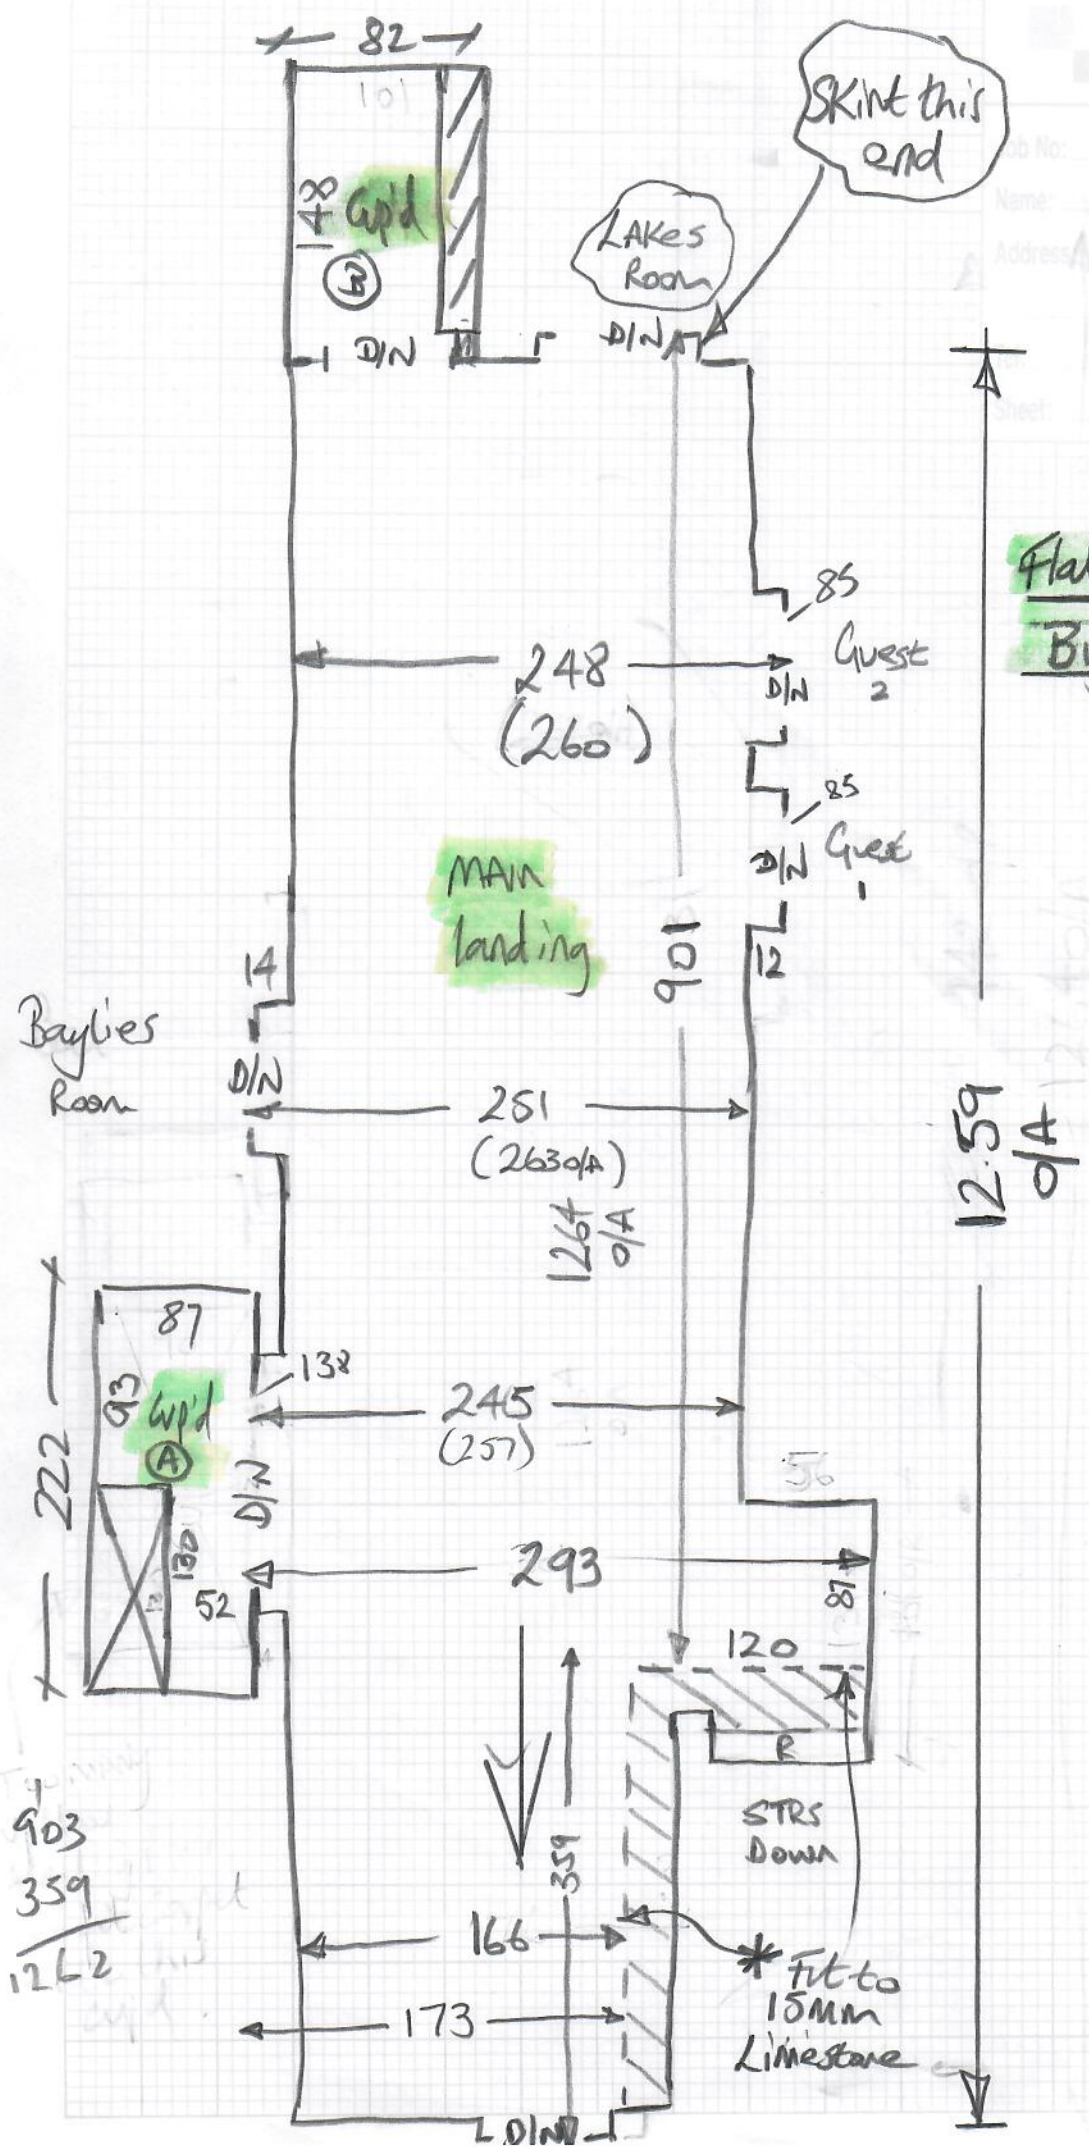


Flatweave Classics
Big Boucle - Down

R18826
 Indie Interiors
 Heronswood

Job No:
 Name:
 Address:
 Tel:
 Sheet:

3 of 3

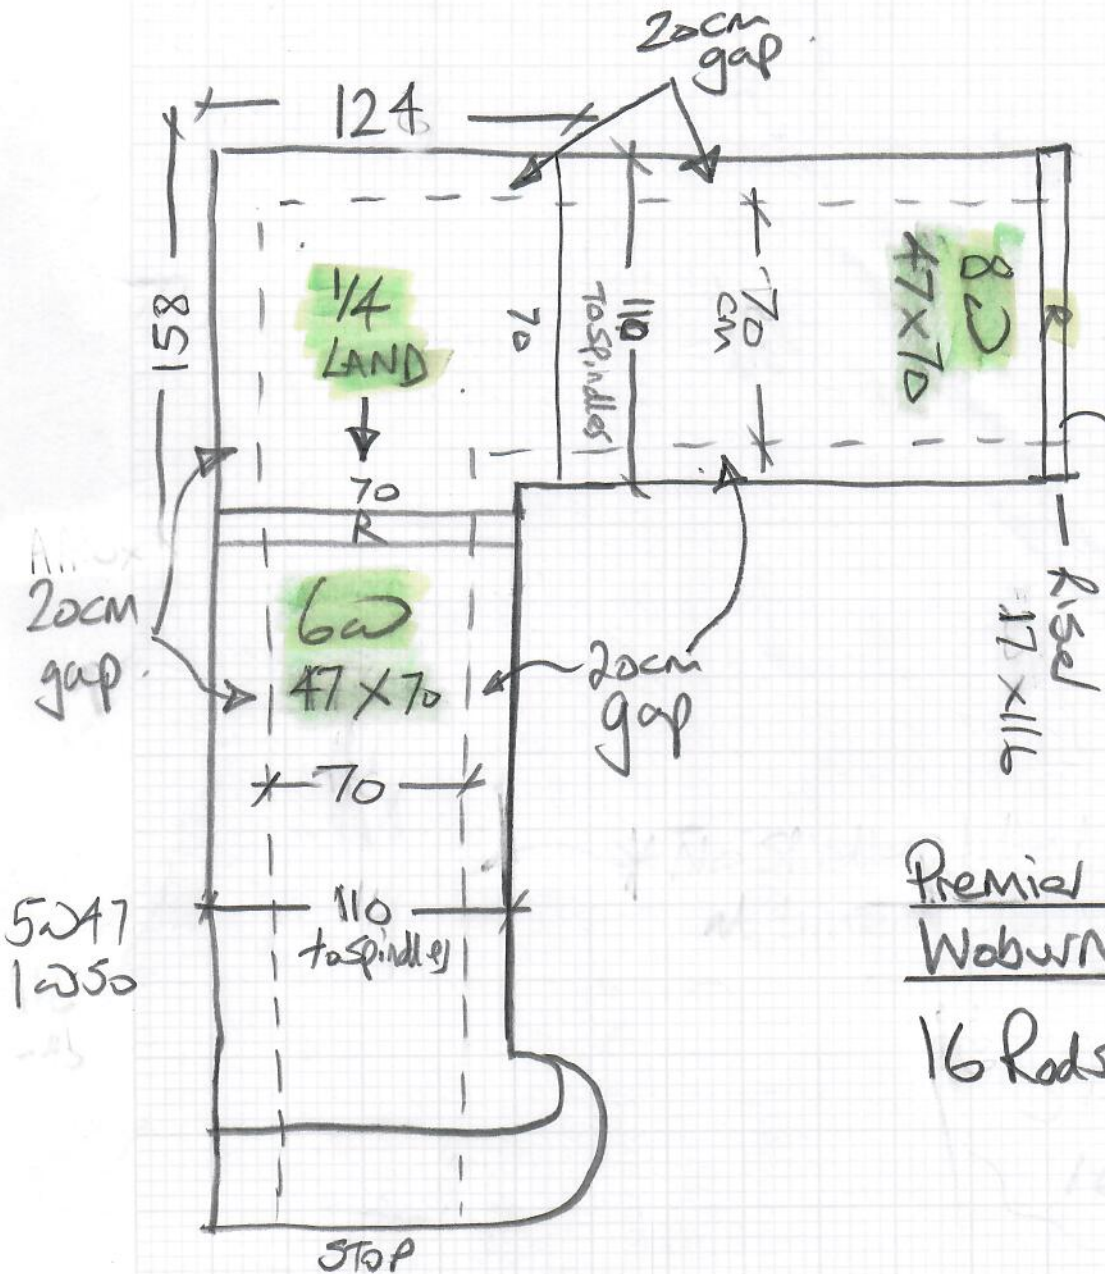

Premier 1/2" STAIRRODS
Woburn - Antique Bronze
 16 Rods @ 80cm

* STAIRS are Limestone
 Stick glue on treads + DTP glue on Risers with Tappits
 STAIRcase Company to drill holes for 'stairrod brackets'

= Zulick, Col. Zulk-613

= Smartstrand Celeste 0240

= Flat weave Classics -
Big Boucle Col. Down } Jon

Jack & Matt
on 27th + 28th June

4th/5th July

Description of Points / Legends

- 0115 - 1000 LED downlight - Flood beam
- 0116 - 1000 LED downlight - Flood beam
- 0117 - 1000 LED downlight - Flood beam
- 0200 - 1000 LED downlight - Flood beam



R18826
Indie Int
Heronswood
6066

Refer to A11 drawings and specifications for
more detailed locations of symbols, data,
and notes. All dimensions are in millimetres
unless otherwise stated.

FIRST FLOOR PLAN
Scale 1:50 @A1